


TYPICAL LONGITUDINAL SECTION OF  
TEMPORARY STEEL DECKING CROSSING STREAM COURSE

1:100

SECTION A - A

1:100

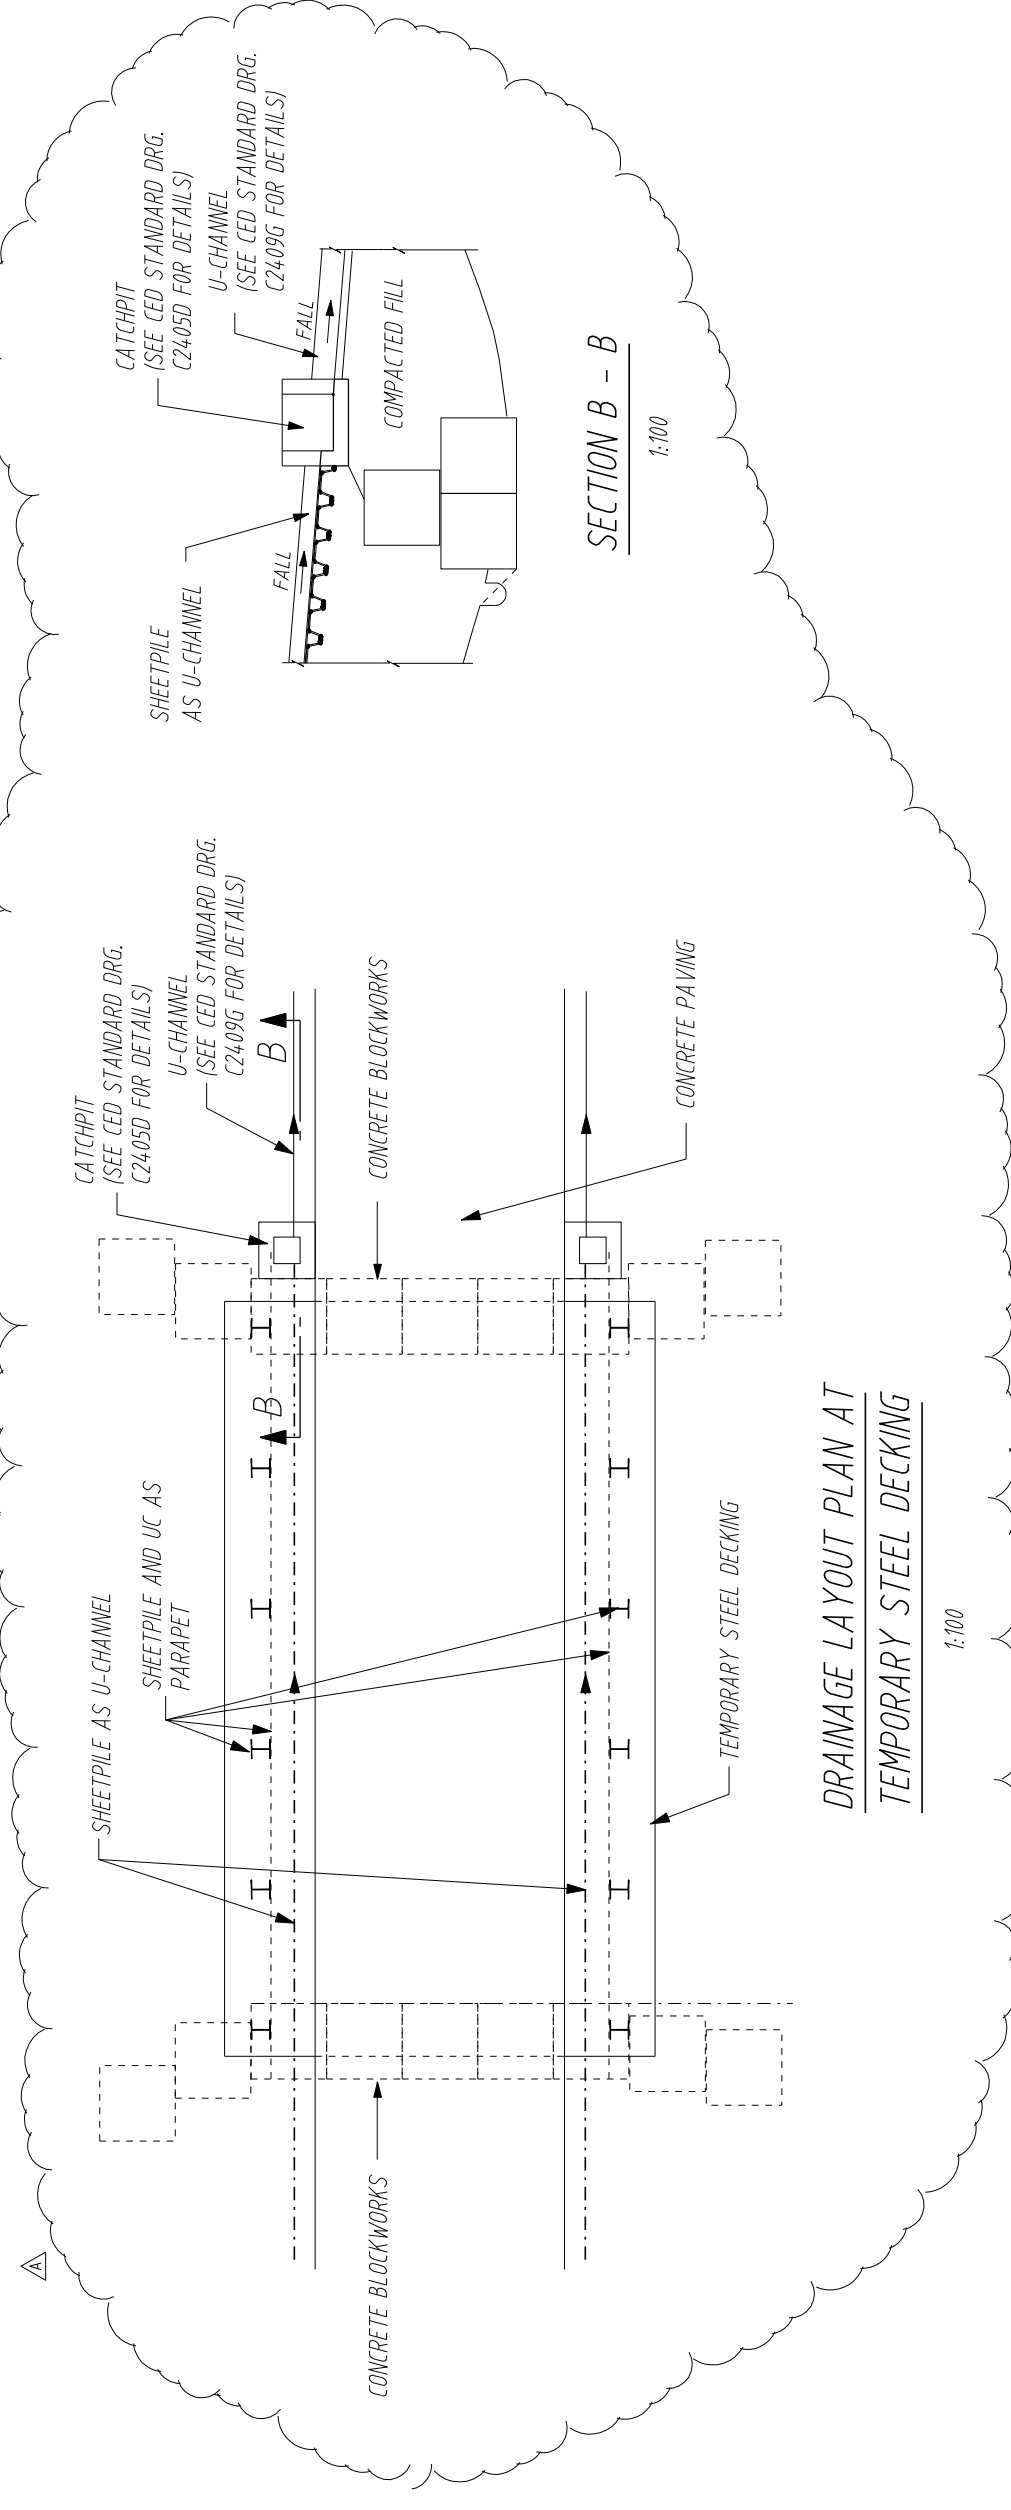

DRAINAGE LAYOUT PLAN AT  
TEMPORARY STEEL DECKING

1:100

SECTION B - B

1:100

Rev.	Date	Drn.	Description	Dep.	Chk.	App'd.
A	30/09/04	V. Liu	REVISED AS NOTED.			

Client  
The Government of the Hong Kong  
Special Administrative Region  
Highways Department

Consulting Engineers  
**Mott**  
Mott  
in Association with  
MVA Hong Kong Ltd  
Architects of 14 Assessments  
MVA's Ltd  
MVA's Ltd  
MVA's Ltd

Joint Contractor  
**CCECC & CRWJ**  
Joint Venture

Project  
Contract No. HV2003/19  
Improvement to Tung Chung Road  
between Lung Tseng Tau  
and Cheung Sha

Draw. Title  
TEMPORARY WORKS FOR SITE FORMATION  
TYPICAL DETAILS OF  
TEMPORARY STEEL DECKING  
CROSSING EXISTING STREAM COURSE

Scale :	Designed WYW	Drawn VL	Checked AI	Approved JG
1:100 @ A3				
	Date OCT 2004	Date OCT 2004	Date OCT 2004	Date OCT 2004

Drawing No.  
TCR/TW/SF/SK003 Rev. A